

SOUND4U AV

416 FALMOUTH AVE.
ELMWOOD PARK, NJ 07407
TEL. 201-406-8916
INFO@SOUND4U.NET

CLIENT

GAYEON, NJ

2020 Hudson St
Fort Lee, NJ 07024

WORK SCOPE

Audio Speaker
Wiring & Location

PROJECT TITLE

Audio System &
Lighting Smart
Control

LEGEND

- AUDIO
- N/A
- NETWORK
- CONTROL

PROJECT NO.

1726079

FILE NAME

SCALE

N/A

DATE

02-19-2017

DRAWN BY


HYUNWOO JO

REVISION


Draft (2/19/2017)
Rev.1 (2/21/2017)
Rev.2 (4/25/2017)
Projector & Audio

DRAWING NO.

AV-001

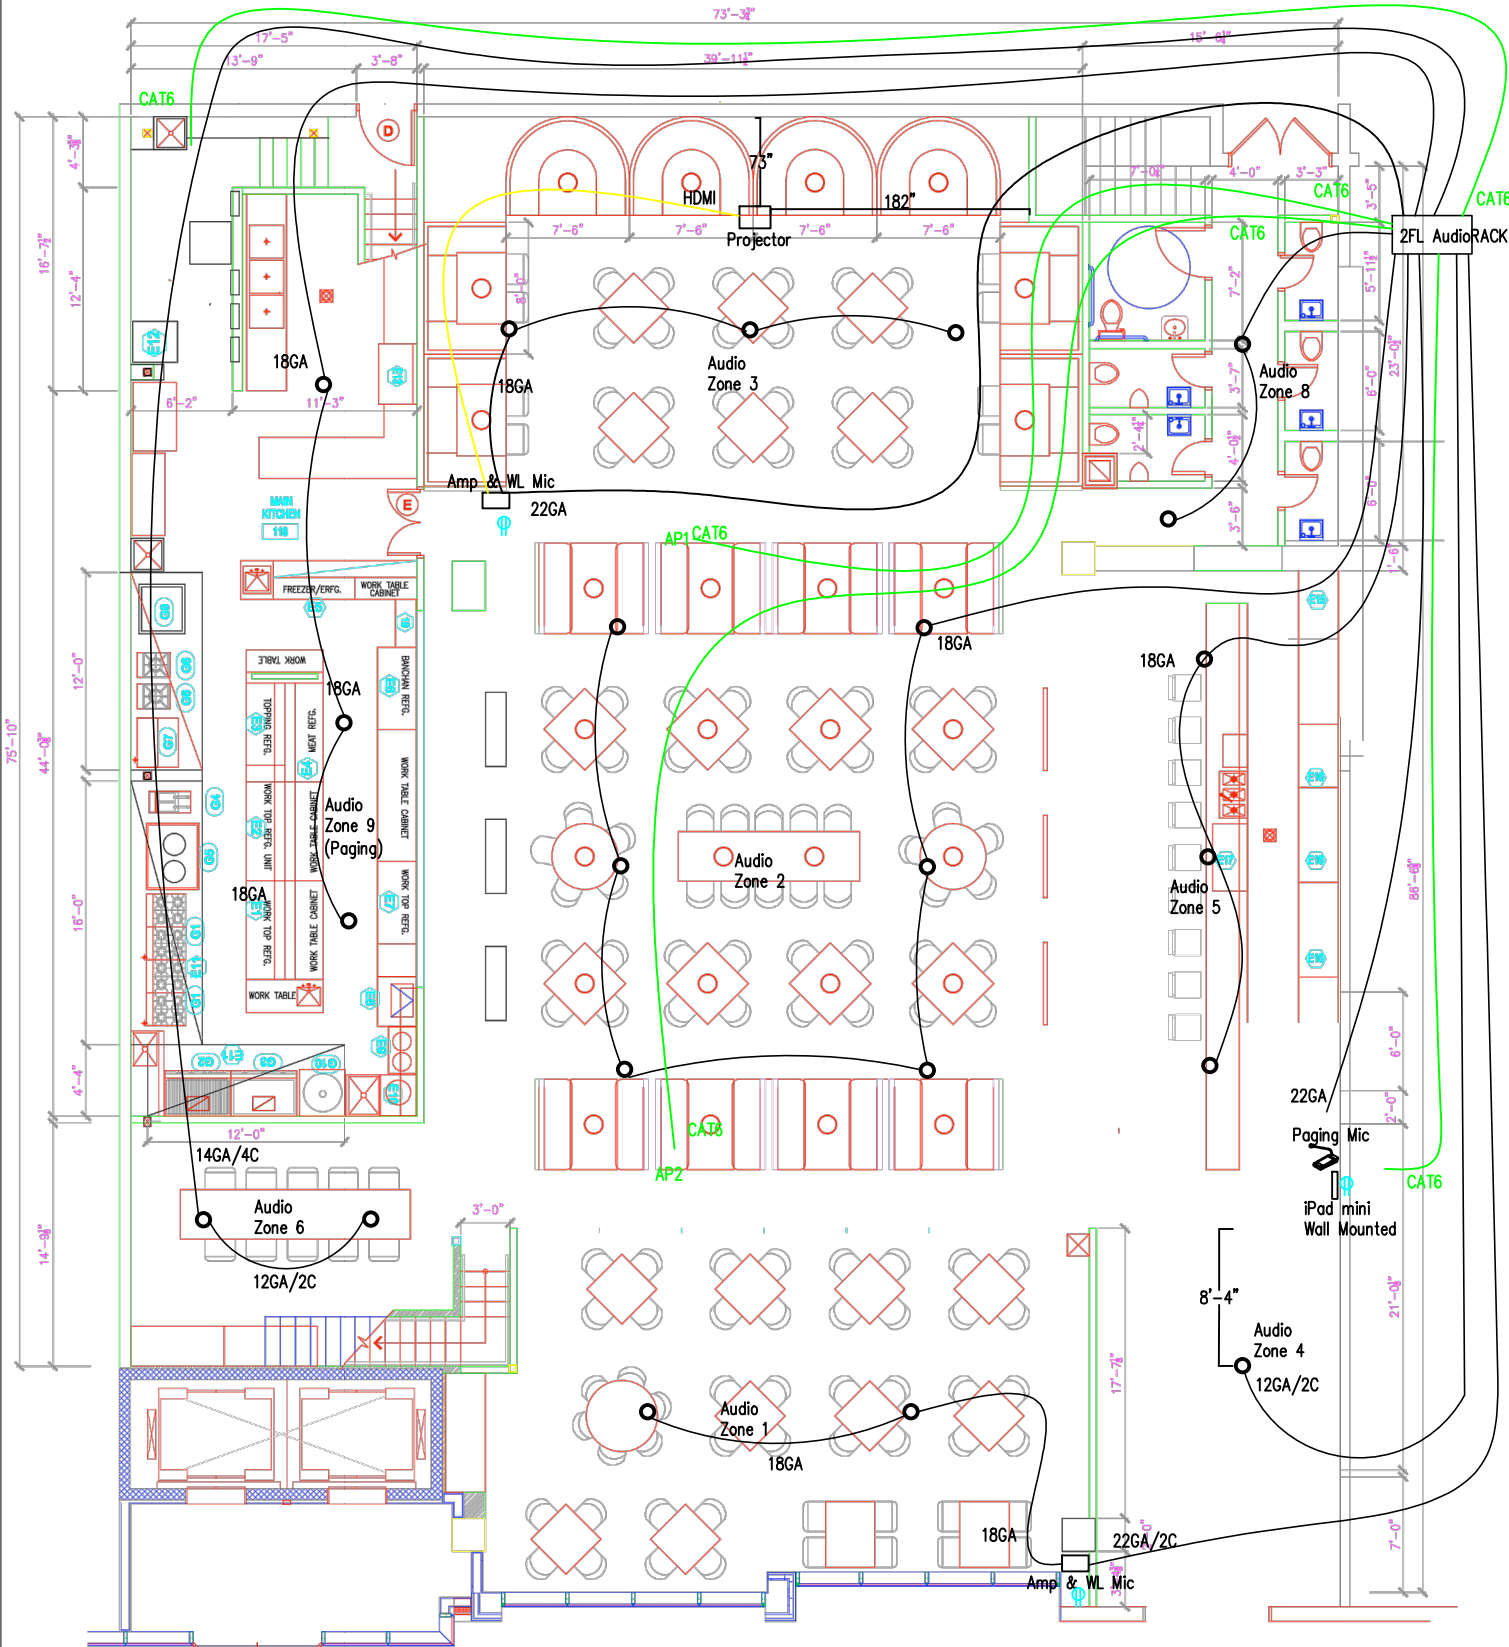

floor plan

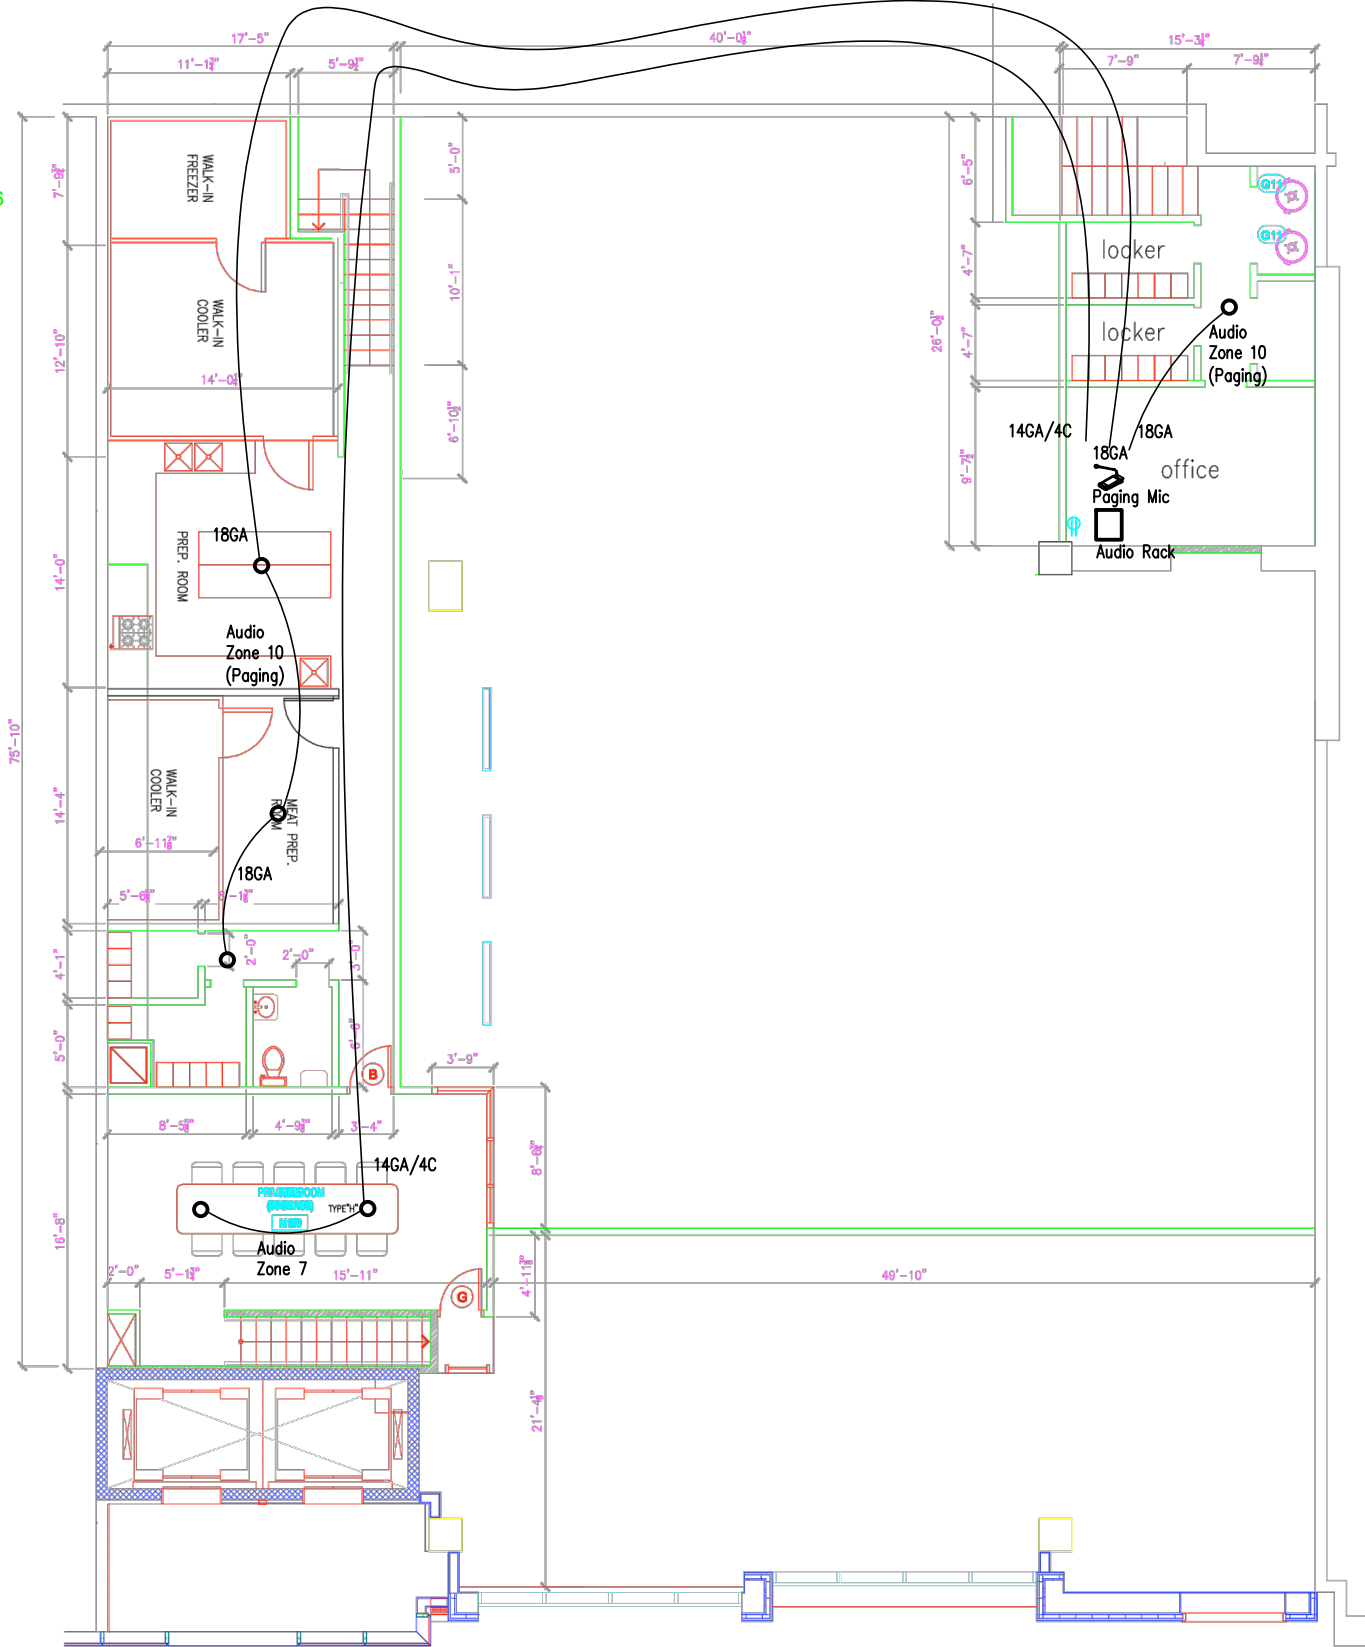

mezzanine

10/6/16